

American Studies Association Annual Meeting

November 8-11, 2018

Westin Peachtree Plaza _Salons C&D

Atlanta, GA


Reserved Booths Marked X



Show Information	
Show Name	American Studies Association Annual Meeting
Show Dates	November 8-11, 2018
Move-In	November 7, 2018
Job #	G113051118
AE	Frank Brown

Inventory as of 01/04/2018

Dimension	Size	Qty	SqFt
10'x10'	100	36	3,600
Totals:		36	3,600

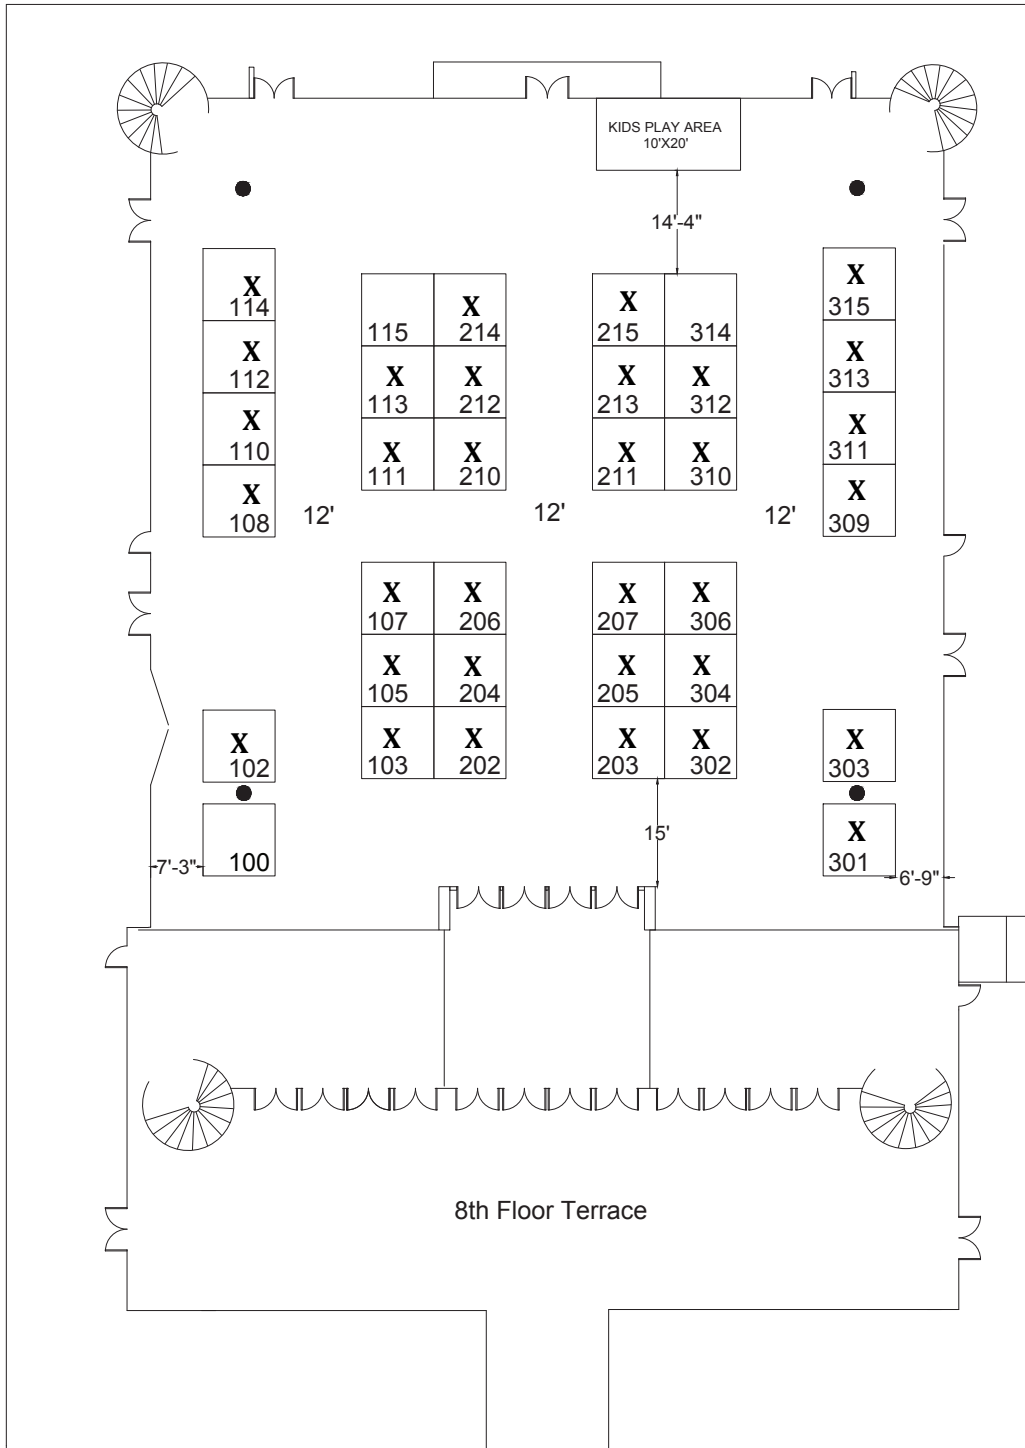

Floor Plan Legend	
FE	Fire Extinguisher
FS	Fire Strobe
FHC	Fire Hose Cabinet

Venue Info	
Building Name	Westin Peachtree Plaza
Hall	Salons C&D
Floor	Floor
Address	210 Peachtree St NW Atlanta, GA 30303

Drawing Information	
File Path	J:\2018\Projects\21_2018 SHOW FLOORPLAN\2018_11_08.dwg
File Name	11_American Studies Association Annual Meeting_20180808_11.dwg
Drawn By	R Perry
Last Saved	11/4/2018 3:31 PM
Saved By	Rperry
Tab	Floorplan
Paper Size	ANSI Full bleed B (11.00 x 17.00 inches)
Scale	? = 1'-0"

1531 Carroll Drive NW
Atlanta, GA 30318
(v) 404-720-8600
(f) 404-720-8750